


PROGRESS SET
NOT FOR
CONSTRUCTION

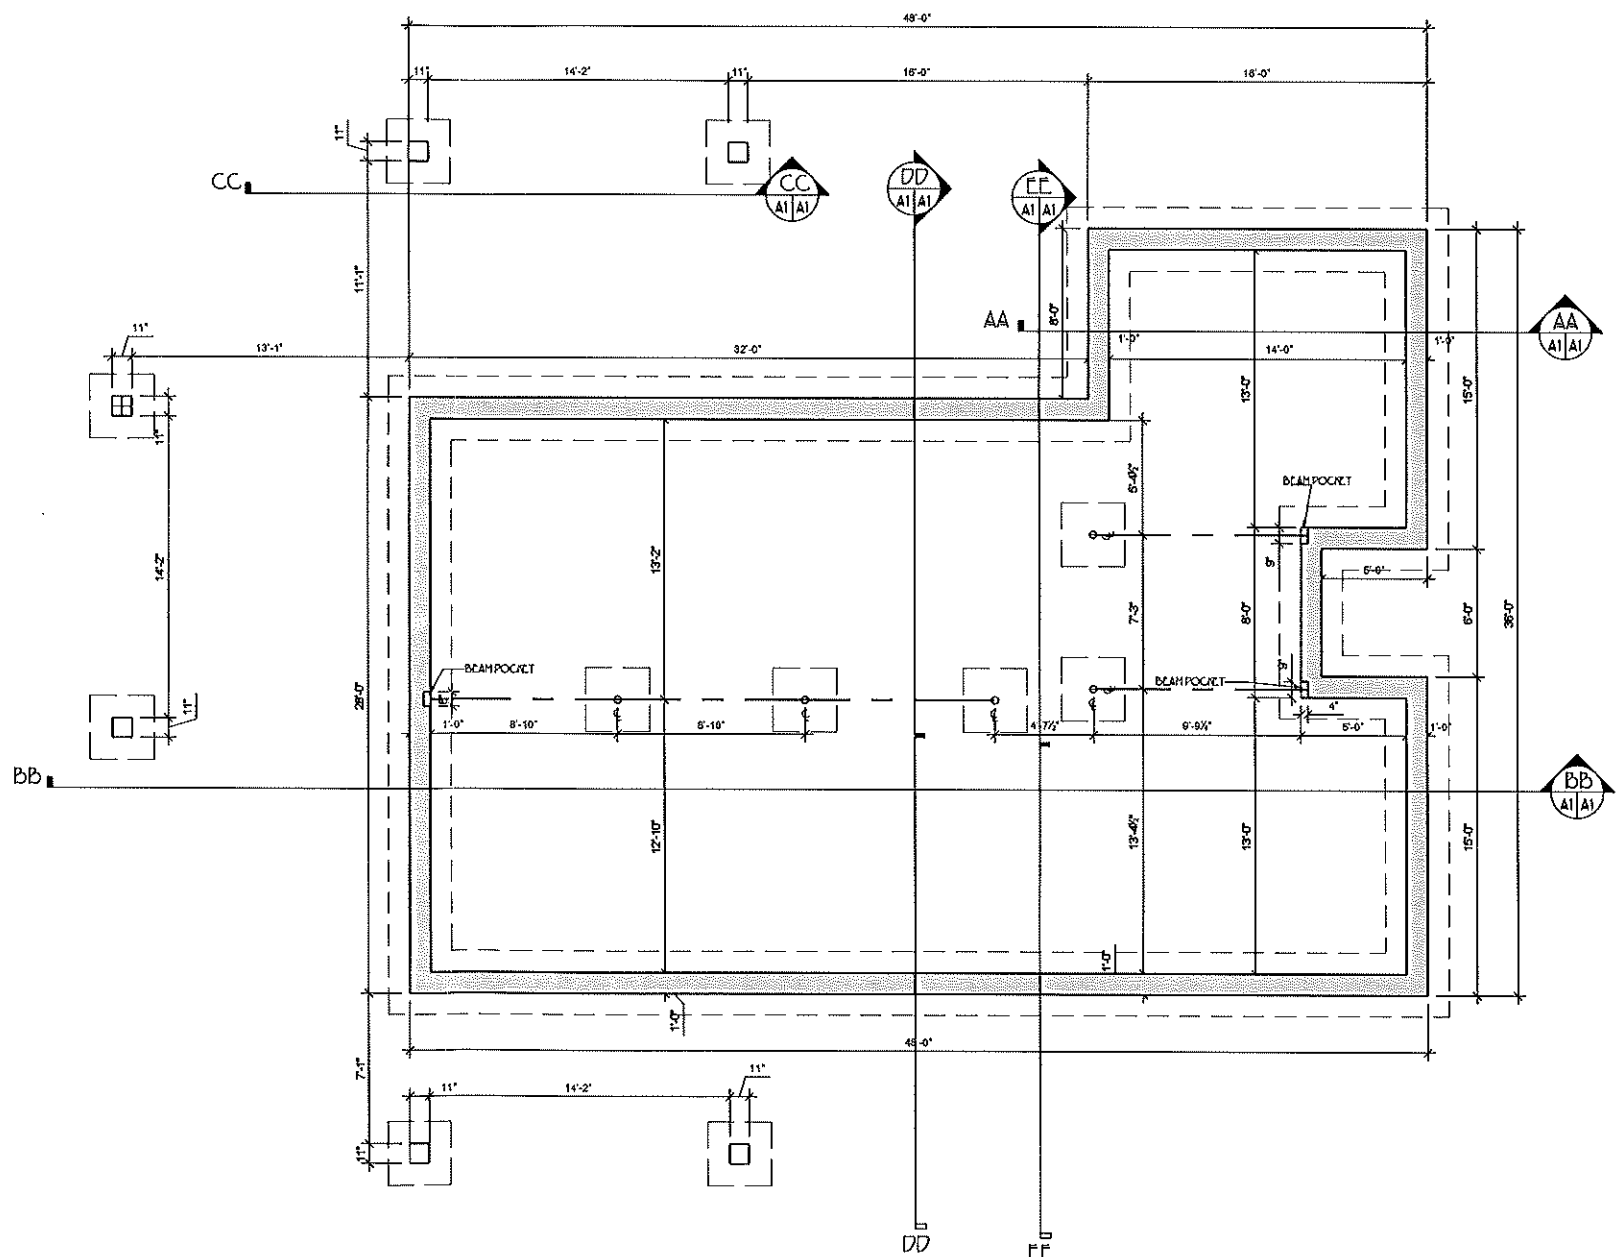


NANTUCKET ARCHITECTURE GROUP LTD.
ARCHITECT - DESIGNER - HISTORIC PRESERVATION -
LAND/CAPL
P/O/T OFFICE BOX 1814
NANTUCKET, MA 02554
TELEPHONE: 508.228.5631 FAX: 508.4284

TOWN OF NANTUCKET
NOBADER FARM PLAYING FIELDS CONCESSION STAND
MAP: 69 PARCEL: 1

FOUNDATION PLAN
SCALE: 1/4" = 1'-0"

NO. 03 2830 13 59388
DRAWING
B.D.G. DEPI
REVISIONS: 10 JUN 2015
REVISIONS.
REVISIONS.
REVISIONS.
D/B, vmm copy right 2015

PROGRESS SET
NOT FOR
CONSTRUCTION

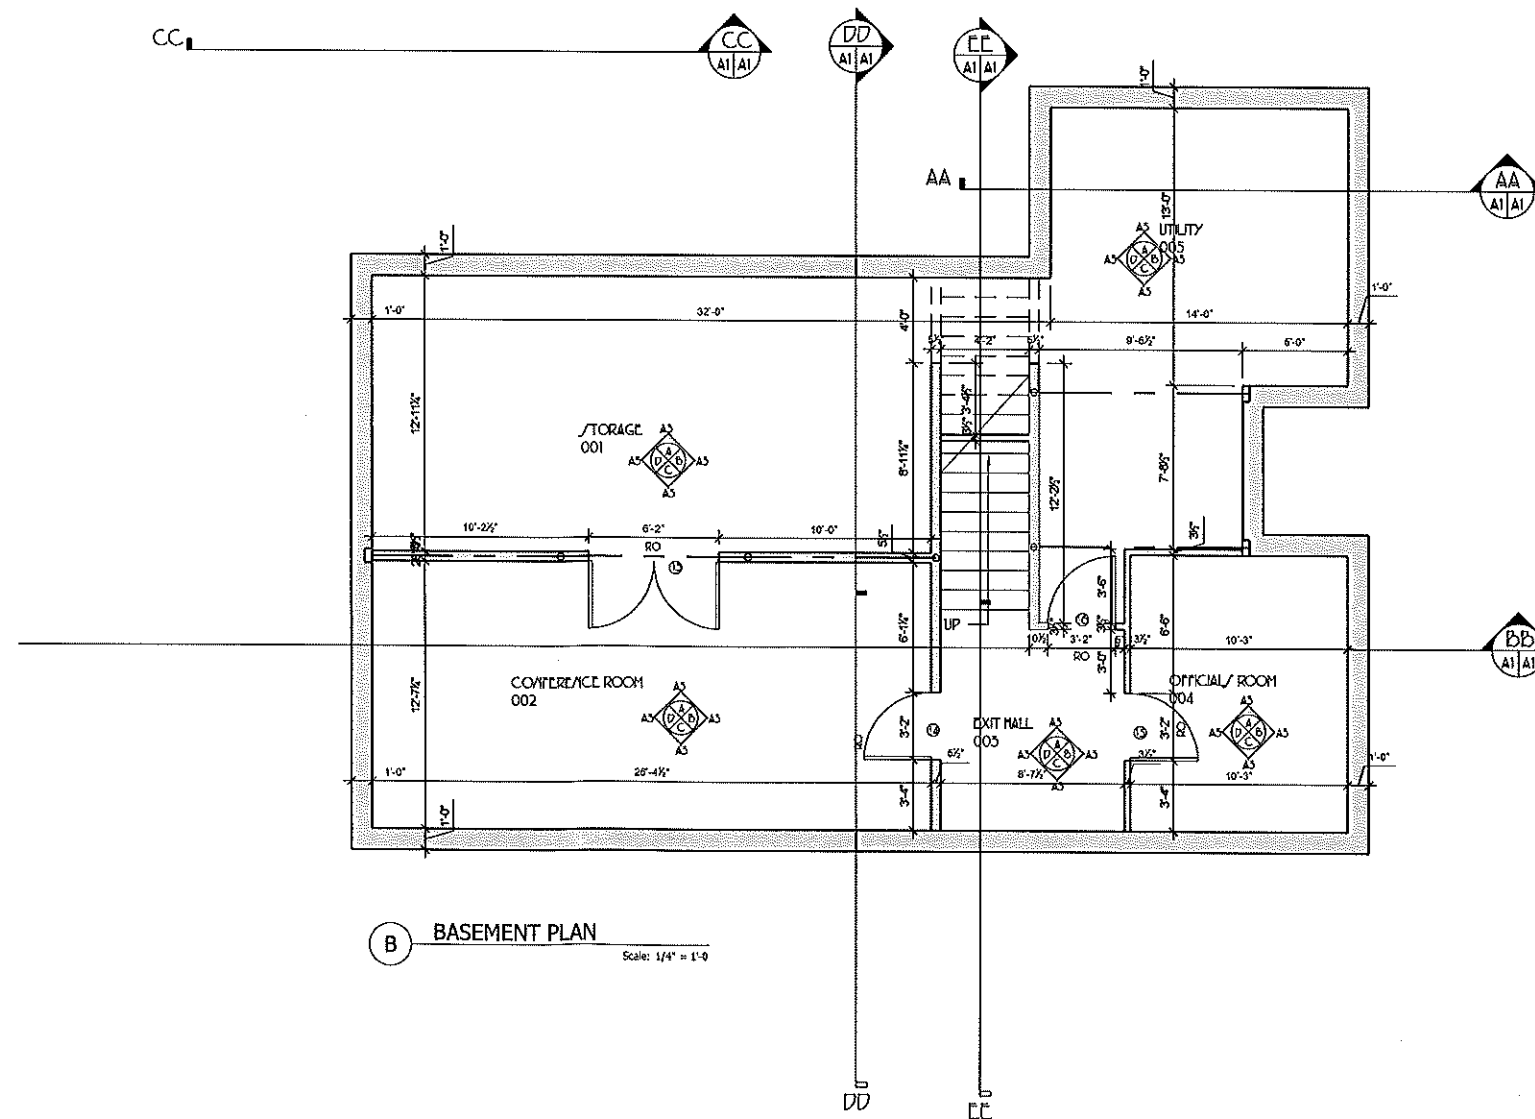


NANTUCKET ARCHITECTURE GROUP LTD.
ARCHITECT / DESIGNER - HISTORIC PRESERVATION -
LAND/CAPE
POST OFFICE BOX 1814
NANTUCKET, MA 02554
TELEPHONE: 508.228.5631 FAX: 508.4284

TOWN OF NANTUCKET
NOBADER FARM PLAYING FIELDS CONCESSION STAND
MAP: 69 PARCEL-1

BASEMENT PLAN
SCALE: 1/4" = 1'-0"
MDC: 03 2013 015 359388
DESIGNER
ENGINEER
REVISIONS: 10/24/2013
REVISIONS
REVISIONS
REVISIONS

130129
A2

PROGRESS SET
NOT FOR
CONSTRUCTION

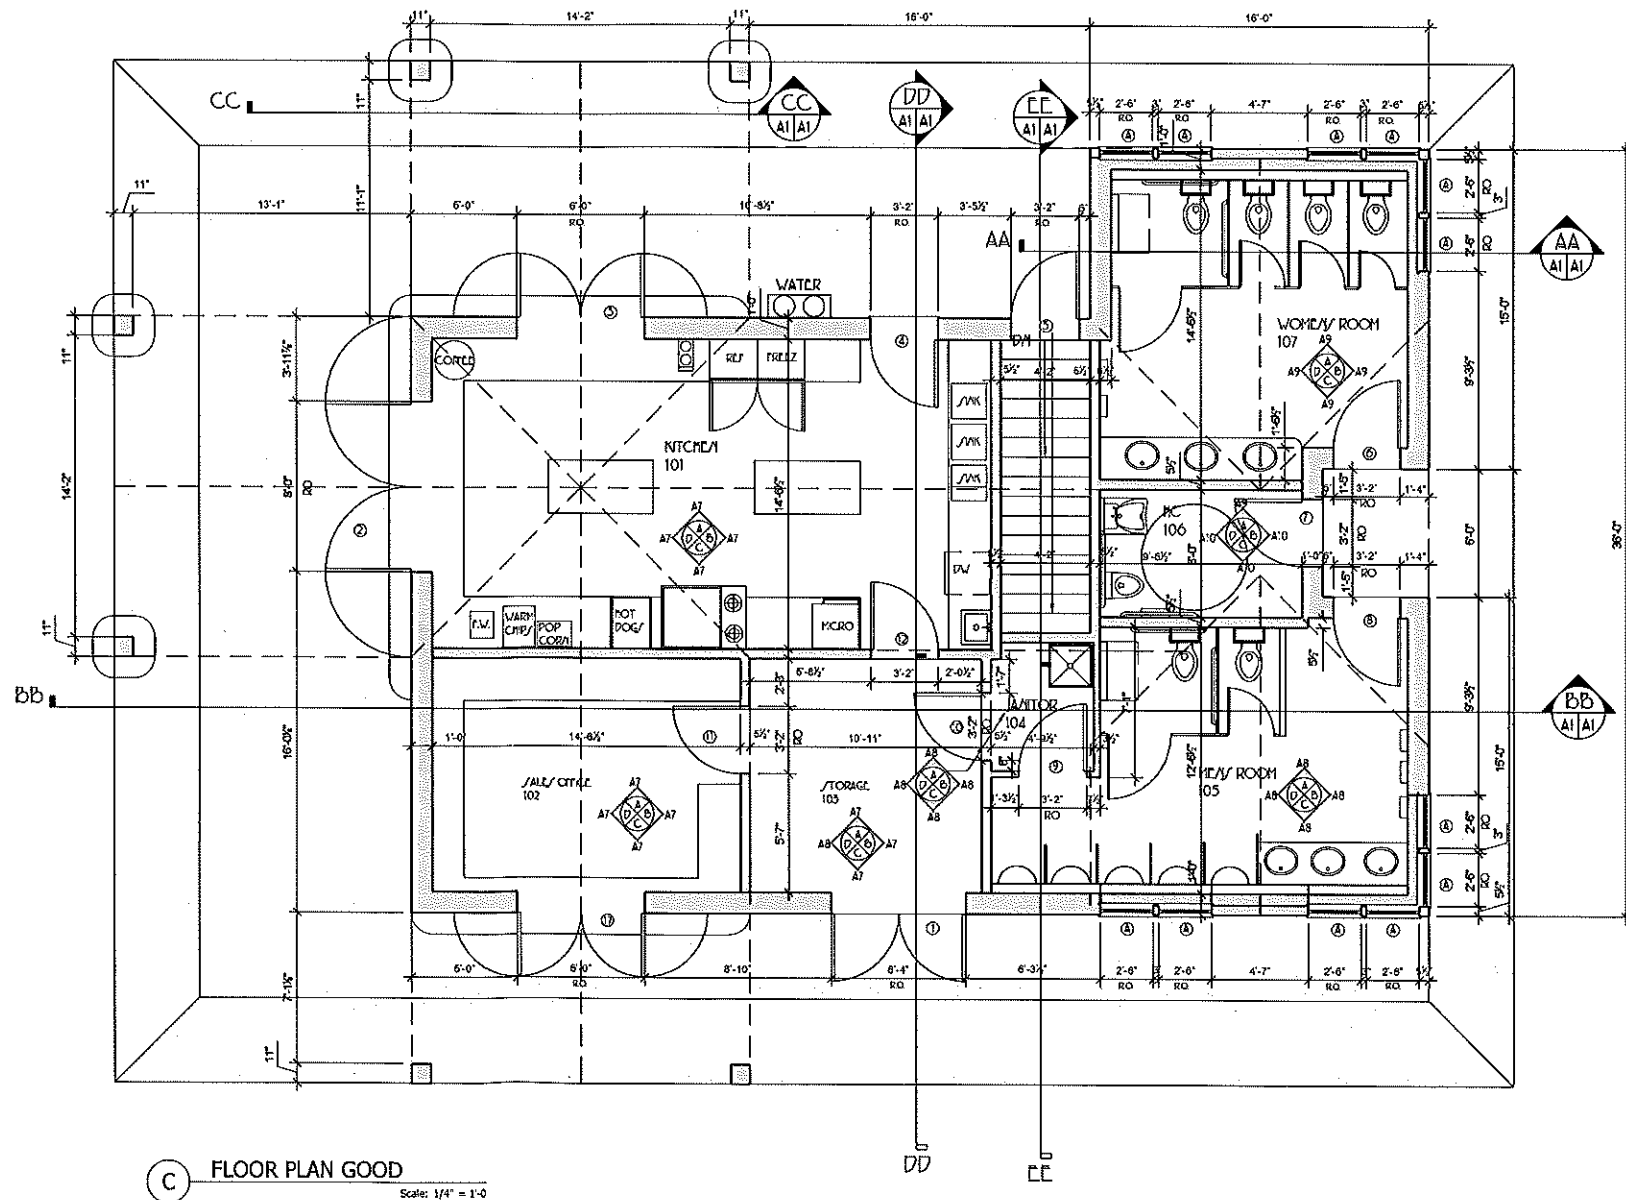

C FLOOR PLAN GOOD
Scale: 1/4" = 1'-0"


NANTUCKET ARCHITECTURE GROUP LTD.
ARCHITECT / DESIGNER - HISTORIC PRESERVATION -
LAND/CAPE
P.O. OFFICE BOX 1814
NANTUCKET, MA 02554
TELEPHONE: 508.228.5631 FAX: 508.4284

TOWN OF NANTUCKET
NOBADER FARM PLAYING FIELDS CONCESSION STAND
MAP: 69 PARCEL: 1

FLOOR PLAN
SCALE 1/4" = 1'-0"
HPC: 05 28 2013 15:59:28
DESIGNER
PLNG DEPT
REVISIONS: 10/2/2015
REVISIONS:
REVISIONS:
REVISIONS:
D/B, VMM copyright 2013
150129

A3

PROGRESS SET
NOT FOR
CONSTRUCTION

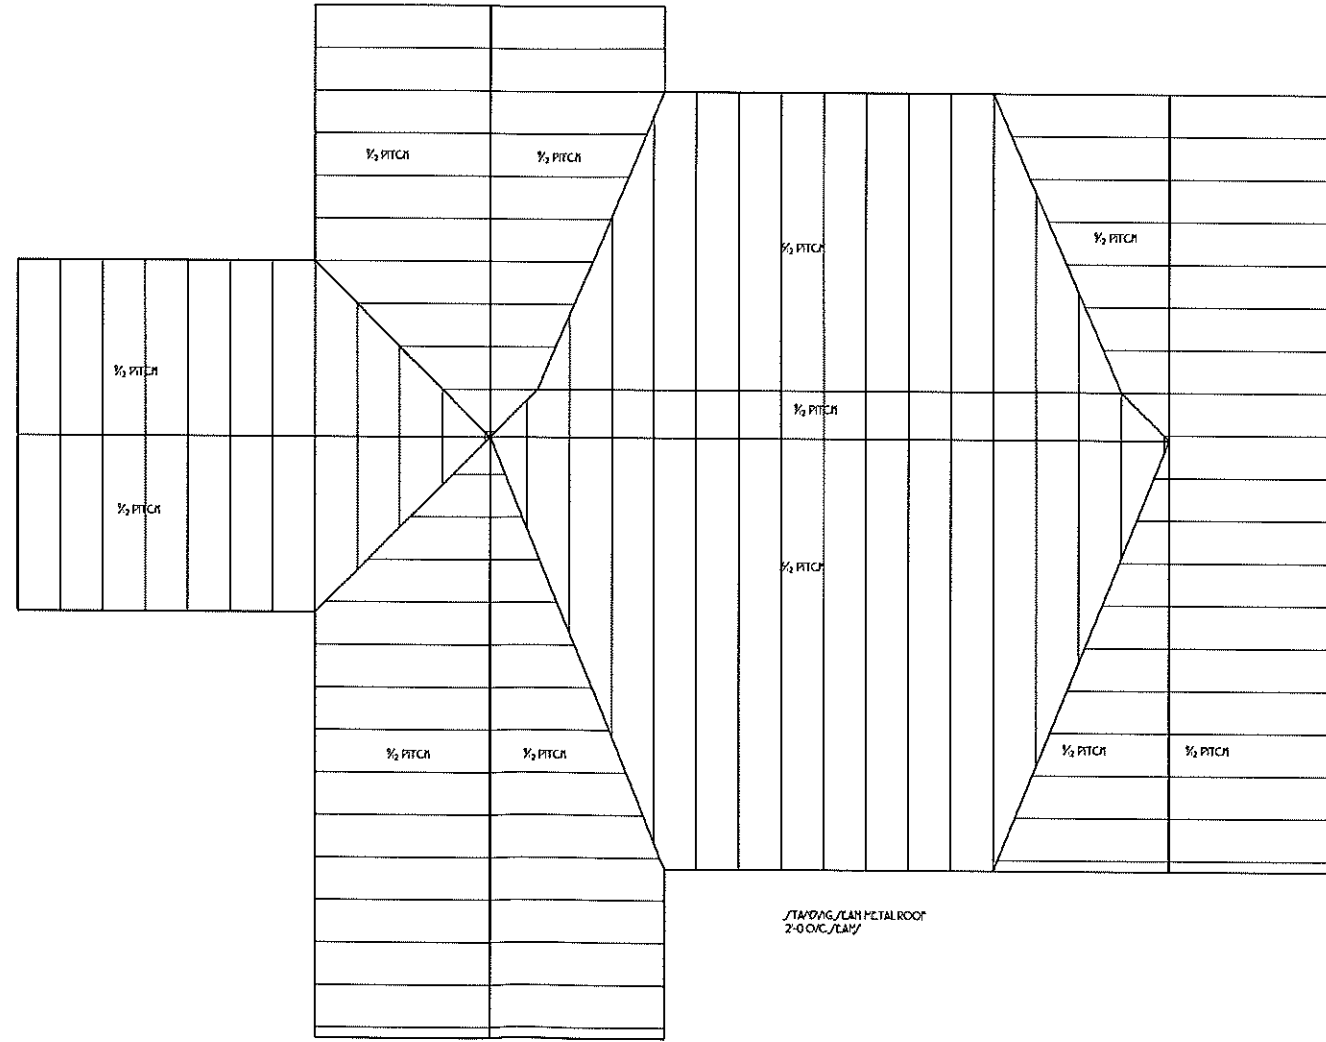

STANDARD LAMINATED ROOF
2-0 O.C./LAP

D ROOF PLAN
Scale: 1/4" = 1'-0"

NANTUCKET ARCHITECTURE GROUP LTD.
ARCHITECT / DESIGNER / HISTORIC PRESERVATION -
LAND/CAPE
P.O. OFFICE BOX 1814
NANTUCKET, MA 02554
TELEPHONE: 508.228.5651 FAX: 508.4284

TOWN OF NANTUCKET
NOBADER FARM PLAYING FIELDS CONCESSION STAND
MAP: 69 PARCEL: 1

ROOF PLAN

SCALE: 1/4" = 1'-0"

DATE: 05/26/2015 10:59:26 AM

DESIGNER:

REVISED: 10/21/2015

REVISED:

REVISED:


REVISED:

REVISED:

D/B, with copyright 2015

150129


A4

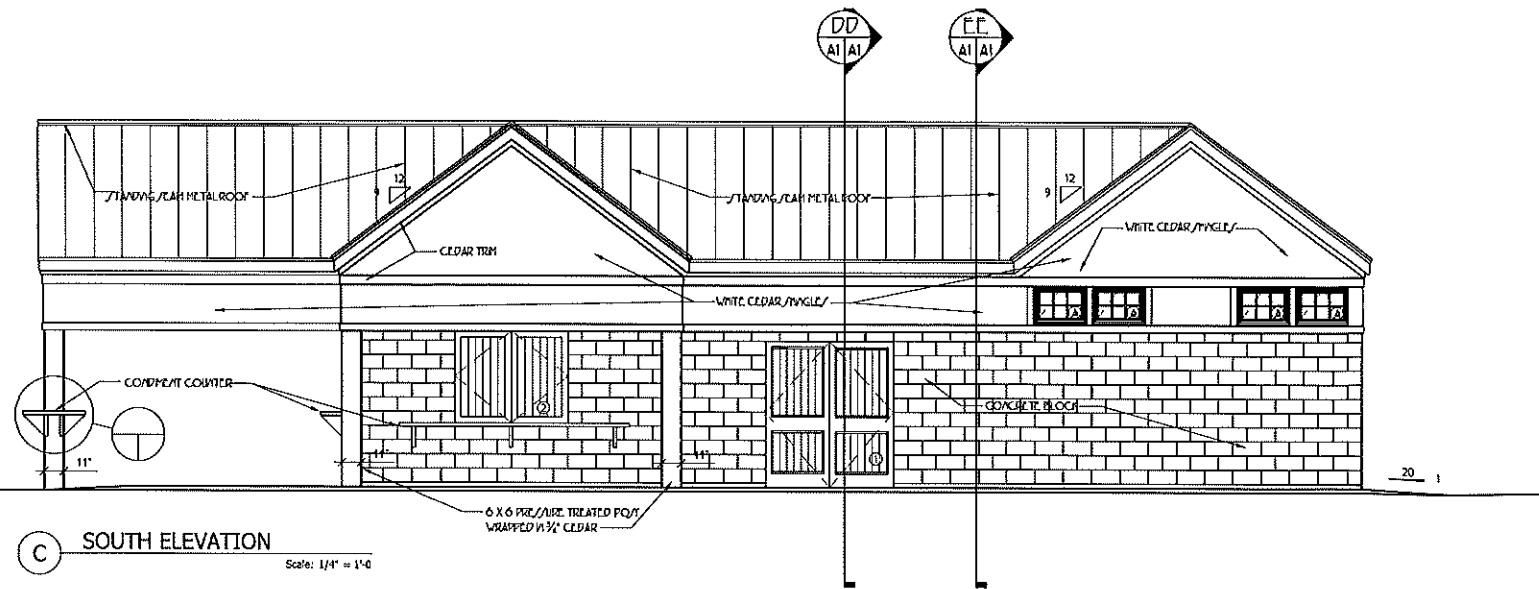

C SOUTH ELEVATION
Scale: 1/4" = 1'-0"

WINDOW/SCHEDULE				
LETTER	MANUFACTURER	ROUGH OPENING	UNIT DIMENSION	NOTE
A	ANDERSON/AA261101	2'-6" X 1'-10"	2'-5 1/4" X 1'-9 1/4"	UPGRADE TO COPR

DOOR/SCHEDULE				
NUMBER	MANUFACTURER	ROUGH OPENING	UNIT DIMENSION	NOTE
1	ROGUE VALLEY DOOR/4082-V 1 3/4" MAHOAGANY	6'-2" X 6'-10"	6'-0" X 6'-8"	DOUBLE DOOR-VERTICAL CEDAR V GROOVE-HANDICAP ALUMINUM/ILL
2	CU/TOM	8'-2" X 4'-1"	8'-0" X 4'-0"	DOUBLE DOOR-VERTICAL CEDAR V GROOVE
3	CU/TOM	6'-2" X 4'-1"	6'-0" X 4'-0"	DOUBLE DOOR-VERTICAL CEDAR V GROOVE
4	ROGUE VALLEY DOOR/4082-V 1 3/4" MAHOAGANY	5'-2" X 6'-10"	5'-0" X 6'-8"	DOUBLE DOOR-VERTICAL CEDAR V GROOVE-HANDICAP ALUMINUM/ILL
5	CU/TOM	5'-2" X 4'-1"	5'-0" X 4'-0"	DOUBLE DOOR-VERTICAL CEDAR V GROOVE
6	ROGUE VALLEY DOOR/4082-V 1 3/4" MAHOAGANY	5'-2" X 6'-10"	5'-0" X 6'-8"	DOUBLE DOOR-VERTICAL CEDAR V GROOVE-HANDICAP ALUMINUM/ILL
7	ROGUE VALLEY DOOR/4082-V 1 3/4" MAHOAGANY	5'-2" X 6'-10"	5'-0" X 6'-8"	DOUBLE DOOR-VERTICAL CEDAR V GROOVE-HANDICAP ALUMINUM/ILL
8	ROGUE VALLEY DOOR/4082-V 1 3/4" MAHOAGANY	5'-2" X 6'-10"	5'-0" X 6'-8"	DOUBLE DOOR-VERTICAL CEDAR V GROOVE-HANDICAP ALUMINUM/ILL

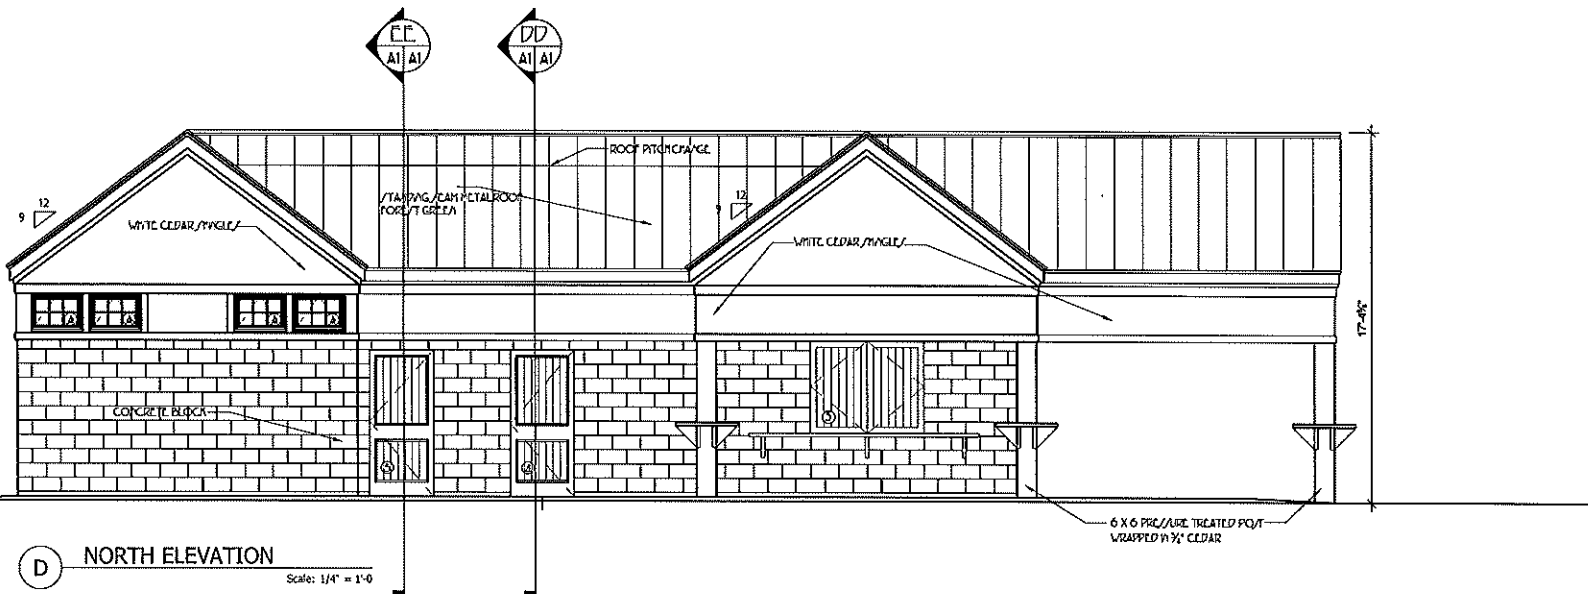


D NORTH ELEVATION
Scale: 1/4" = 1'-0"

PROGRESS SET
NOT FOR
CONSTRUCTION



E WEST ELEVATION
Scale: 1/4" = 1'-0"

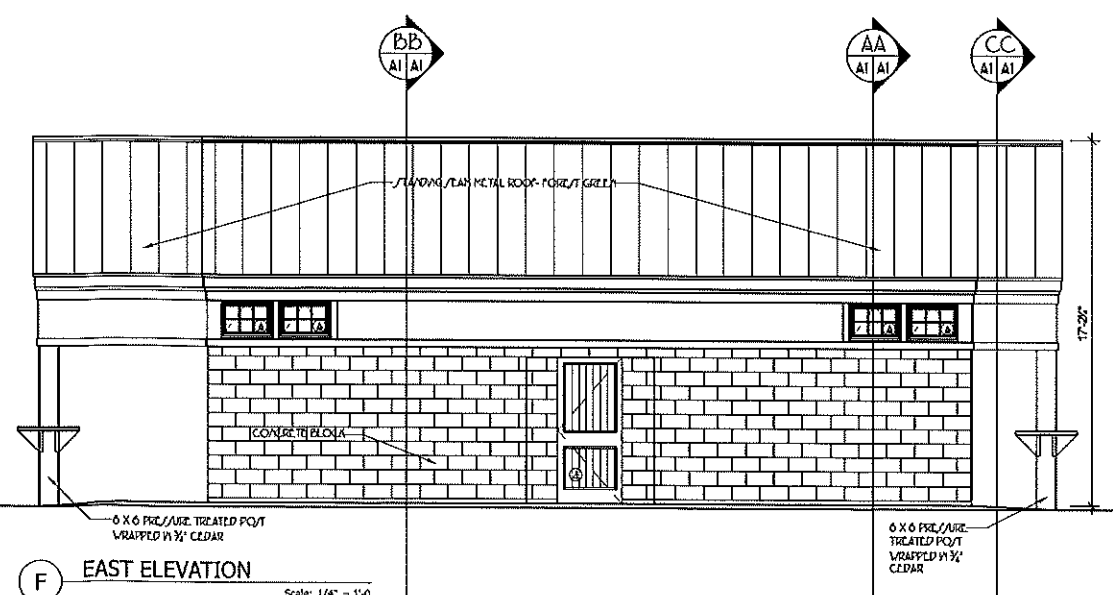


F EAST ELEVATION
Scale: 1/4" = 1'-0"

NANTUCKET ARCHITECTURE GROUP LTD.
ARCHITECT - DESIGNER - HISTORIC PRESERVATION -
LAND/CAPL
POST OFFICE BOX 1814
NANTUCKET, MA 02554
TELEPHONE: 508.228.5631 FAX: 508.4284


TOWN OF NANTUCKET
MOBADER FARM PLAYING FIELDS CONCESSION STAND
MAP: 69 PARCEL: 1

EXTERIOR ELEVATION/ SCALE 1/4" = 1'-0"
NPC:05262015, #59388
ISSUE
BLDG DEPT
REVISIONS: 10/20/2015
REVISIONS
REVISIONS
REVISIONS
D/B: vmm copyright 2015
130129


A5

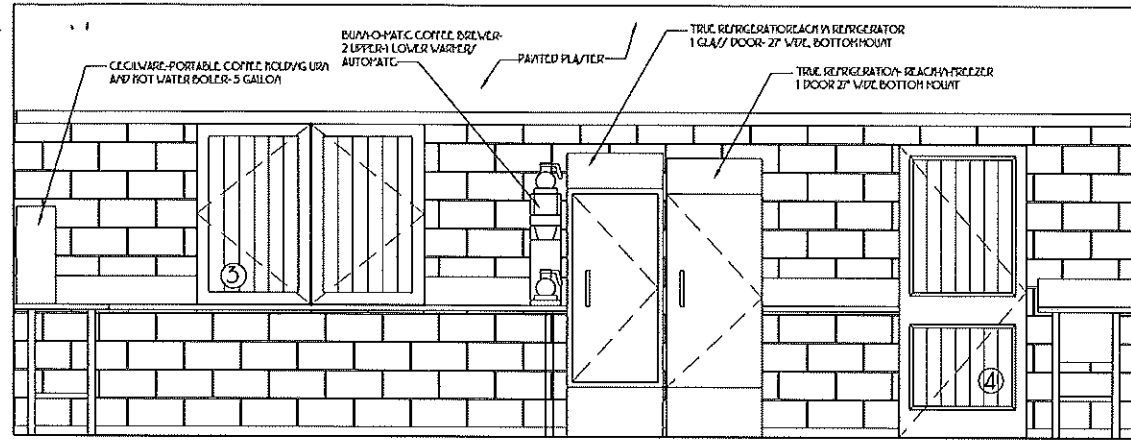


A KITCHEN 101 ELEVATION A
Scale: 1/2" = 1'-0"

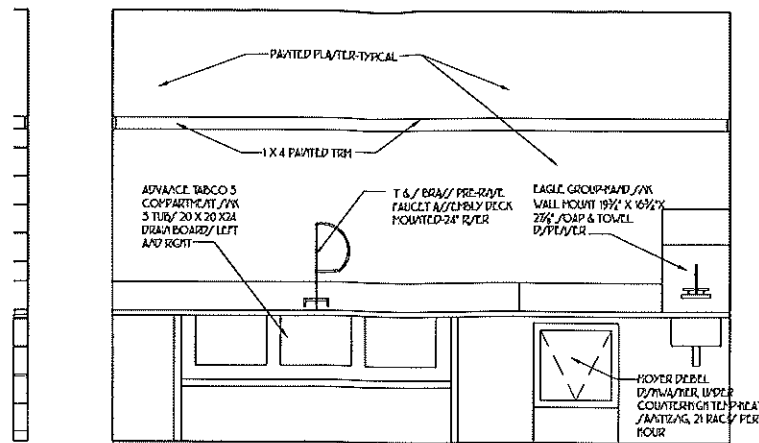


B KITCHEN 101 ELEVATION B
Scale: 1/2" = 1'-0"

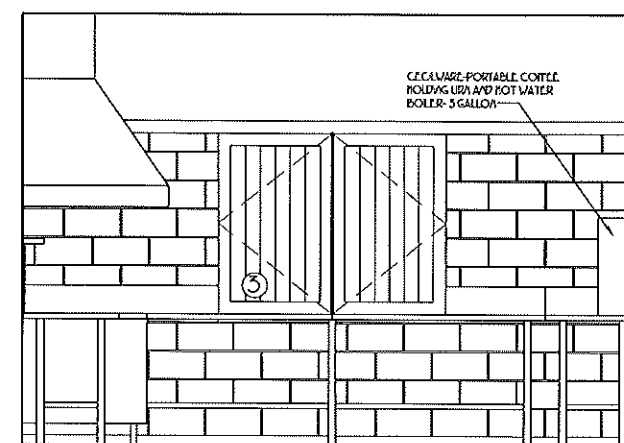


D KITCHEN 101 ELEVATION D
Scale: 1/2" = 1'-0"

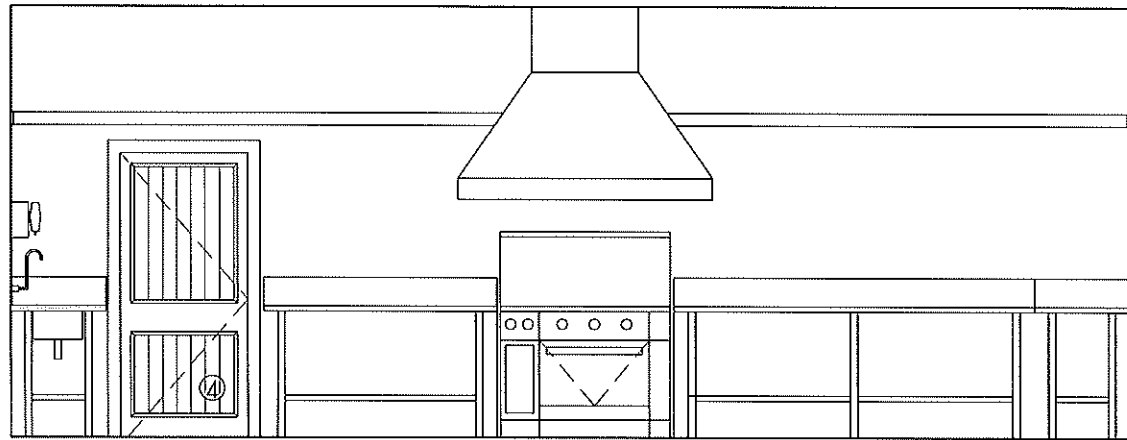


C KITCHEN 101 ELEVATION C
Scale: 1/2" = 1'-0"

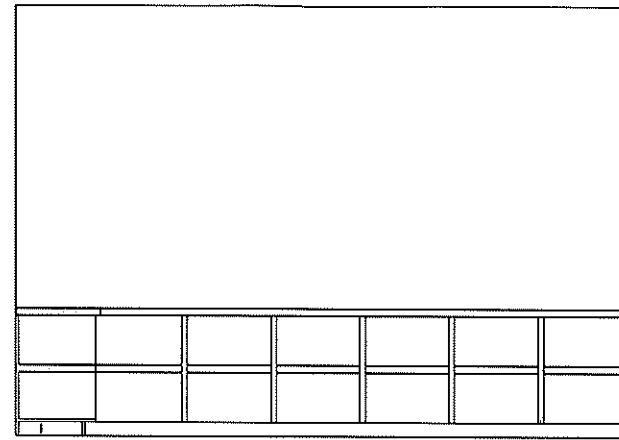


A SALES/OFFICE 102 ELEVATION A
Scale: 1/2" = 1'-0"

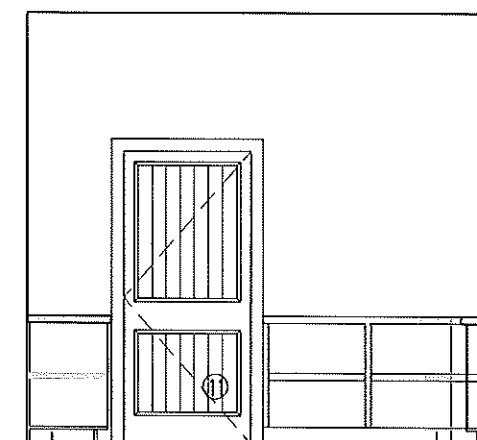


B SALES/OFFICE 102 ELEVATION B
Scale: 1/2" = 1'-0"

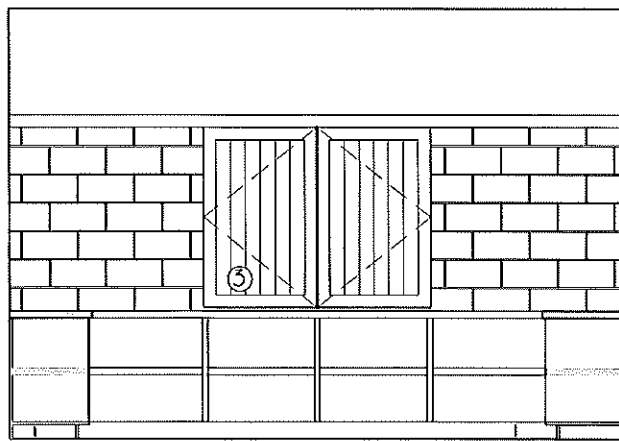


C SALES/OFFICE 102 ELEVATION C
Scale: 1/2" = 1'-0"

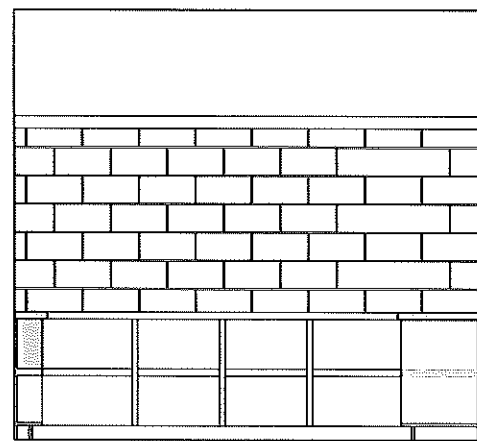


D SALES/OFFICE 102 ELEVATION D
Scale: 1/2" = 1'-0"

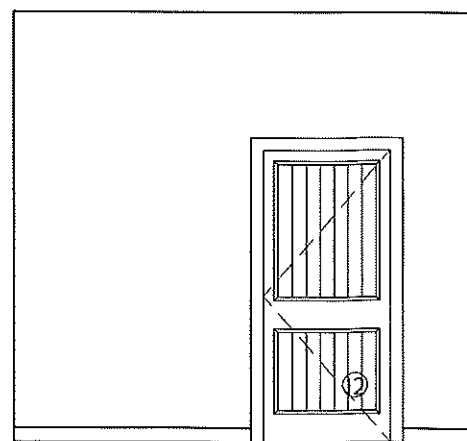

A STORAGE 103 ELEVATION A
Scale: 1/2" = 1'-0"

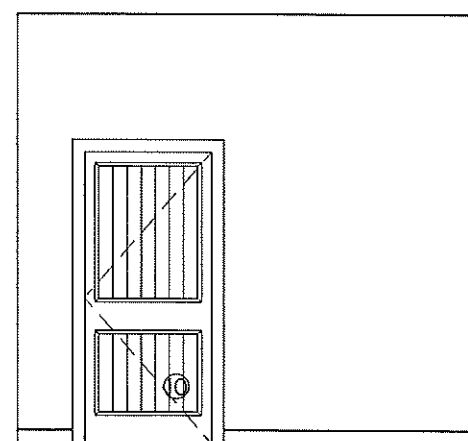

B STORAGE 103 ELEVATION B
Scale: 1/2" = 1'-0"

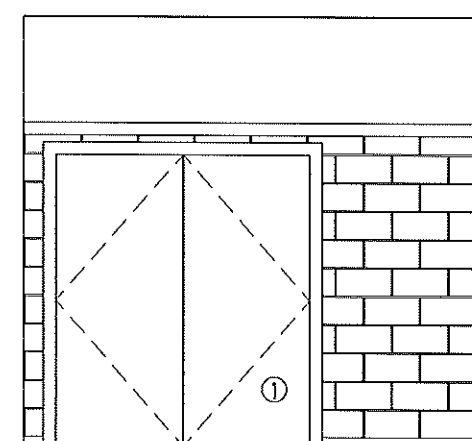

C STORAGE 103 ELEVATION C
Scale: 1/2" = 1'-0"

PROGRESS SET
NOT FOR CONSTRUCTION


NANTUCKET ARCHITECTURE GROUP LTD.
ARCHITECT - DESIGNER - HISTORIC PRESERVATION -
LAND/CAPE
P.O. OFFICE BOX 1814
NANTUCKET, MA 02554
TELEPHONE: 508.228.5631 FAX: 508.4284

TOWN OF NANTUCKET
MOBACER FARM PLAYING FIELDS CONCESSION STAND
MAP: 69 PARCEL: 1


INTERIOR
ELEVATIONS
SCALE 1/4" = 1'-0"
MDC-05.26.2015, #59588
DESIGNER
REVISED 10, JUNE, 2015
REVISIONS
REVISIONS
REVISIONS
1/2" B. vmm copyright 2015

150129


A7

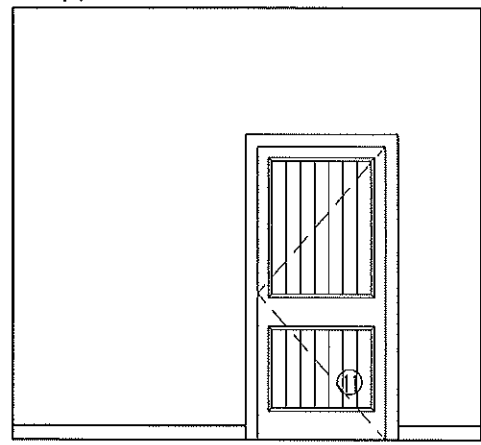


D STORAGE 103 ELEVATION D
Scale: 1/2" = 1'-0"

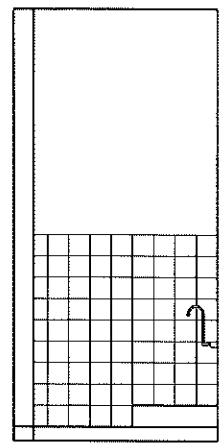


A JANITOR 104
Scale: 1/2" = 1'-0"

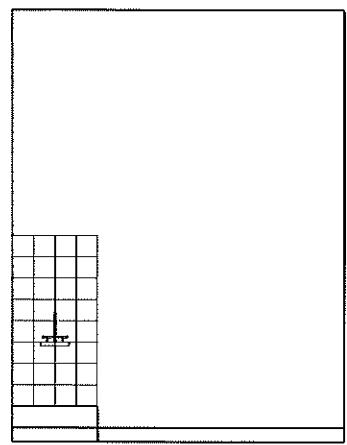


B JANITOR 104
Scale: 1/2" = 1'-0"

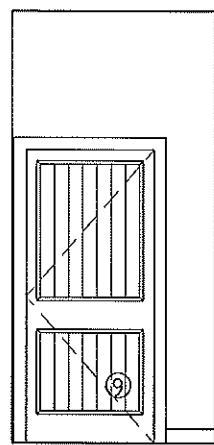

C JANITOR 104
Scale: 1/2" = 1'-0"

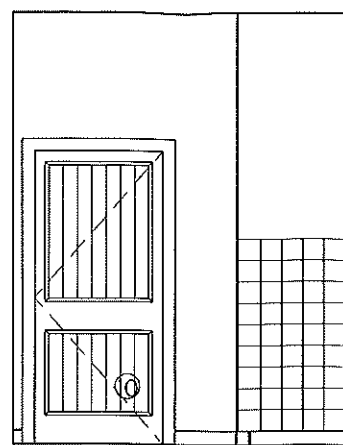


D JANITOR 104
Scale: 1/2" = 1'-0"

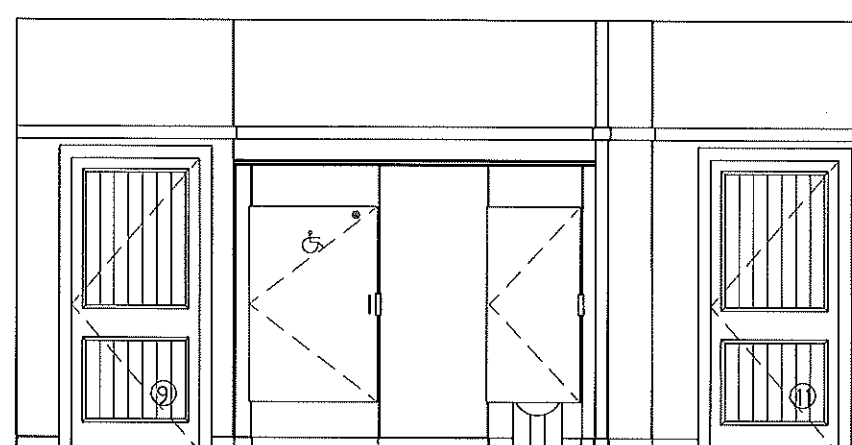


A MENS ROOM 105 ELEVATION A
Scale: 1/2" = 1'-0"


SCALE 1/4" = 1'-0"

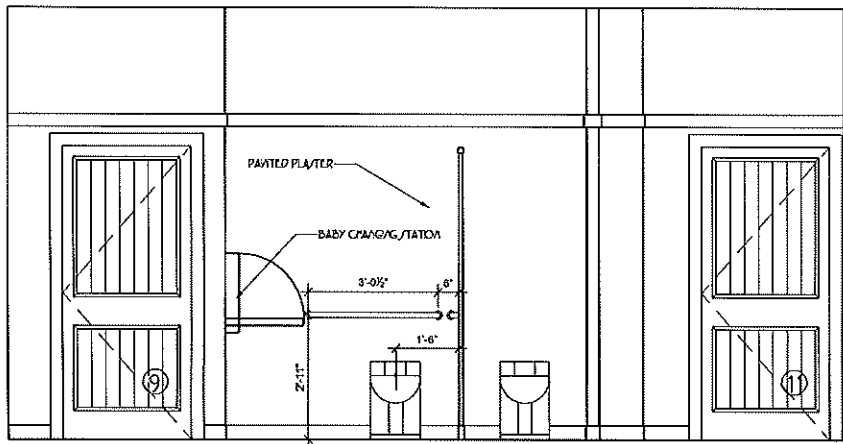

A MENS ROOM 105 ELEVATION A-B
Scale: 1/2" = 1'-0"

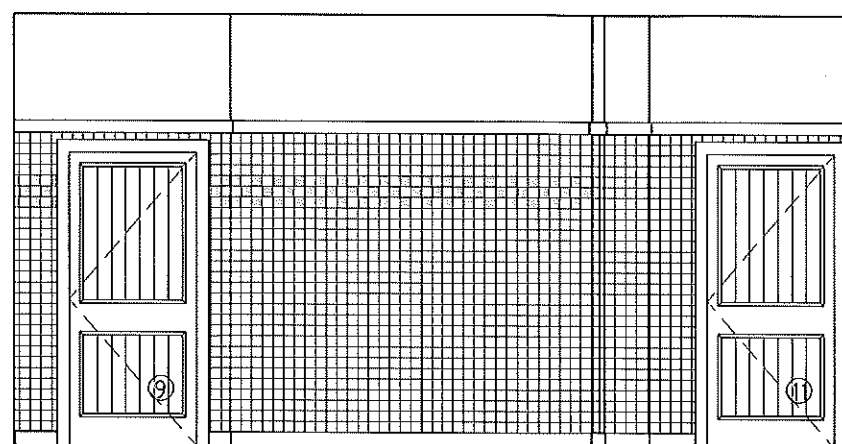


A MENS ROOM 105 ELEVATION A TILE PATTERN
Scale: 1/2" = 1'-0"

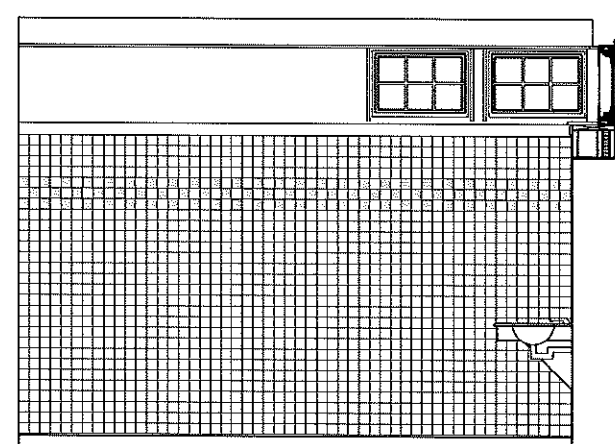


B MENS ROOM 105 ELEVATION B
Scale: 1/2" = 1'-0"


PROGRESS SET
NOT FOR CONSTRUCTION

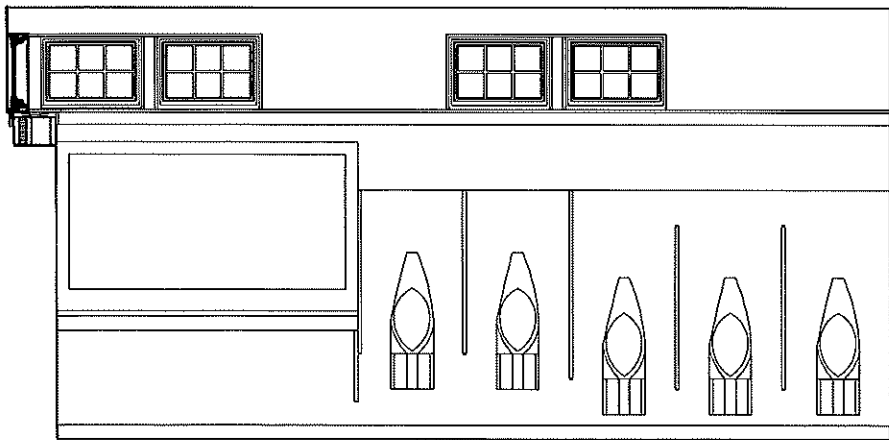

C MENS ROOM 105 ELEVATION C
Scale: 1/2" = 1'-0"

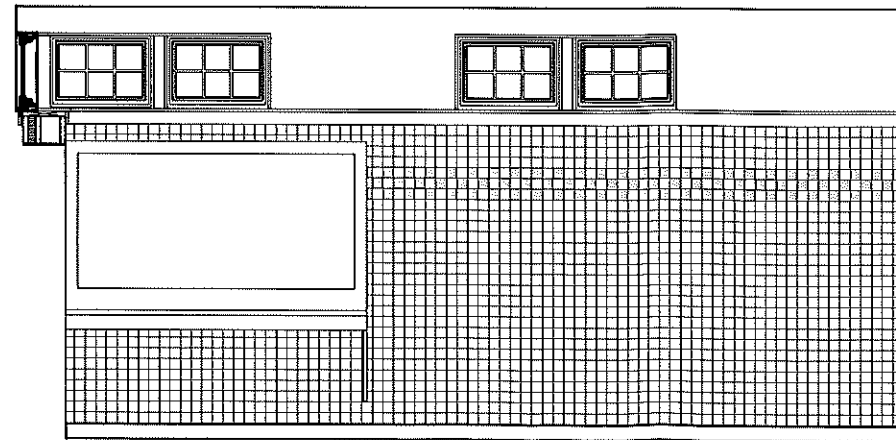

C MENS ROOM 105 ELEVATION C TILE PATTERN
Scale: 1/2" = 1'-0"

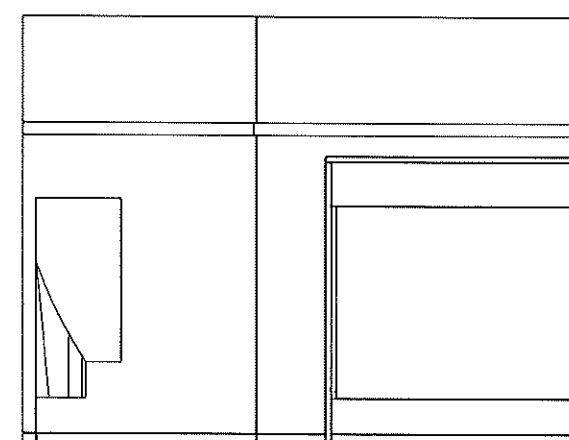


D MENS ROOM 105 ELEVATION D
Scale: 1/2" = 1'-0"

NANTUCKET ARCHITECTURE GROUP LTD.
ARCHITECTS - DESIGNERS - HISTORIC PRESERVATION -
LANDSCAPE
PO/PT OFFICE BOX 1814
NANTUCKET, MA 02554
TELEPHONE: 508.228.5651 FAX: 525.4284

TOWN OF NANTUCKET
MOBADER FARM PLAYING FIELDS CONCESSION STAND
MAP: 69 PARCEL: 1


INTERIOR
ELEVATIONS
SCALE 1/4" = 1'-0"
MDC.03.26.2013, #59388
BOONE
BLDG DEPT.
REVISIONS: 10, JUNE, 2015
REVISIONS.
REVISIONS.
REVISIONS.
D/P ©, www.copyright.org 2015
150129

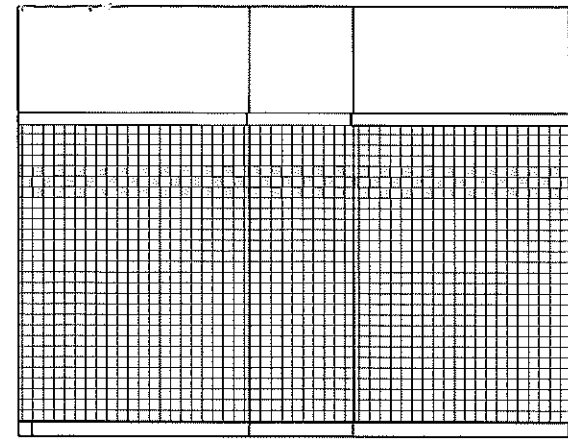


D MENS ROOM 105 ELEVATION D TILE PATTERN
Scale: 1/2" = 1'-0"




A WOMENS ROOM 107 ELEVATION A
Scale: 1/2" = 1'-0"

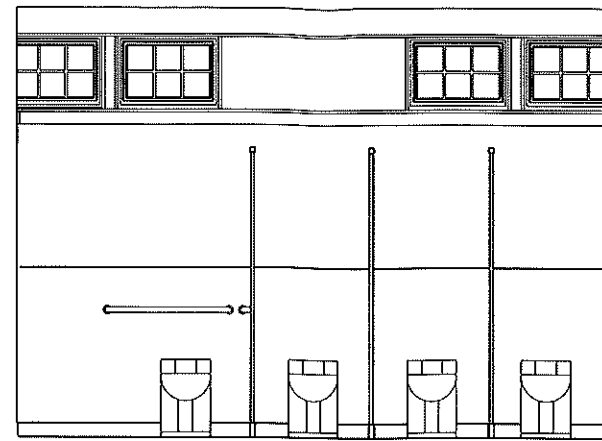


A WOMENS ROOM 107 ELEVATION A (NO DOORS)
Scale: 1/2" = 1'-0"

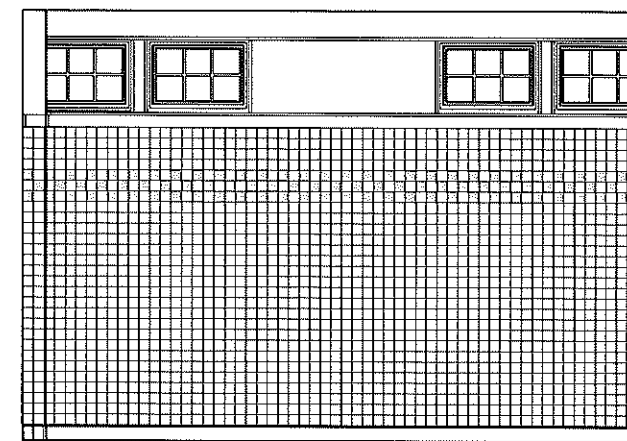


A WOMENS ROOM 107 ELEVATION A TILE PATTERN
Scale: 1/2" = 1'-0"

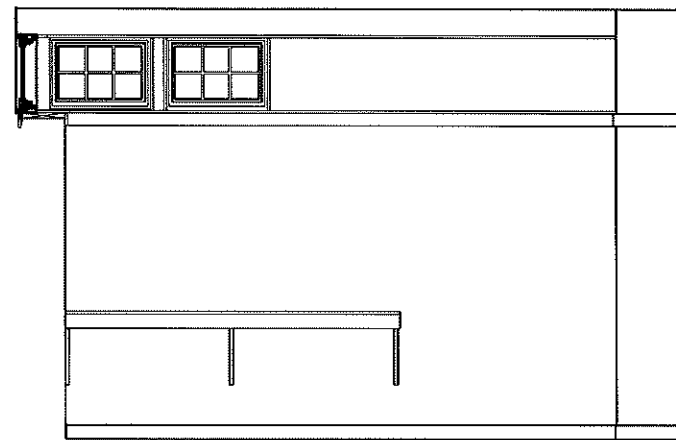


B WOMENS ROOM 107 ELEVATION B
Scale: 1/2" = 1'-0"

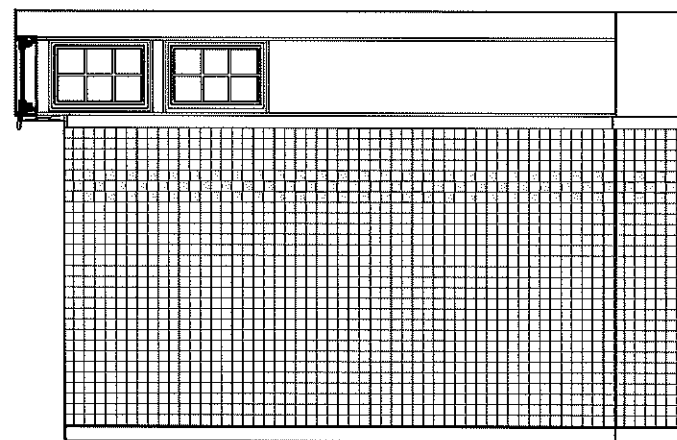


B WOMENS ROOM 107 ELEVATION B TILE PATTERN
Scale: 1/2" = 1'-0"

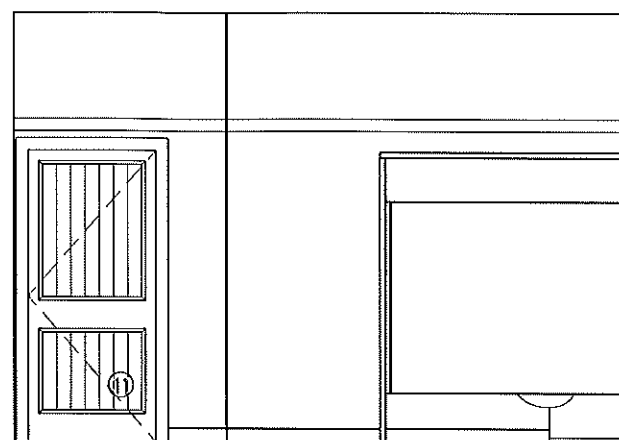


C WOMENS ROOM 107 ELEVATION C
Scale: 1/2" = 1'-0"

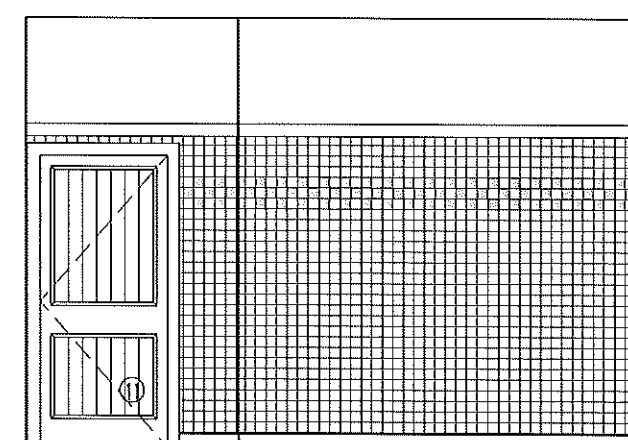


C WOMENS ROOM 107 ELEVATION C TILE PATTERN
Scale: 1/2" = 1'-0"

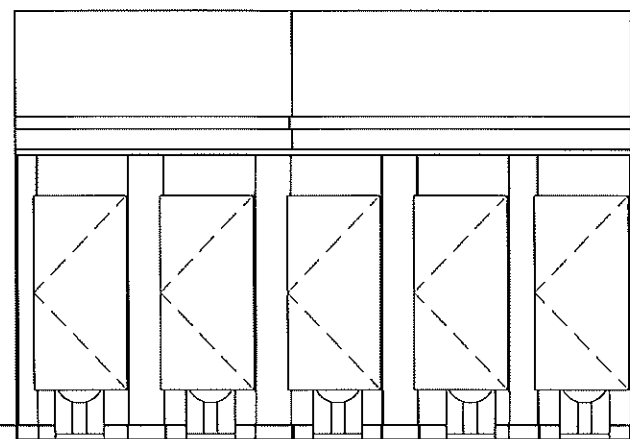


D WOMENS ROOM 107 ELEVATION D
Scale: 1/2" = 1'-0"

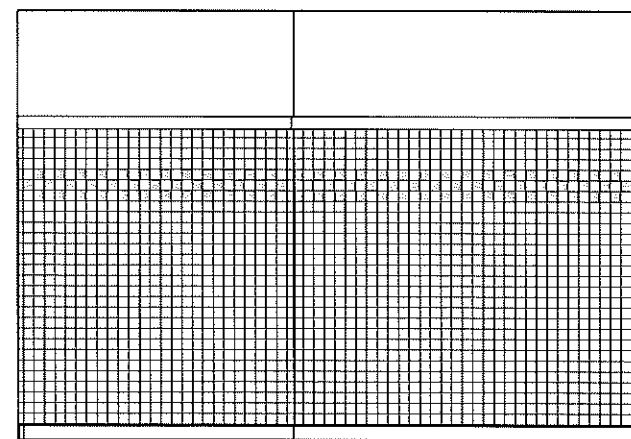

D WOMENS ROOM 107 ELEVATION D TILE PATTERN
Scale: 1/2" = 1'-0"

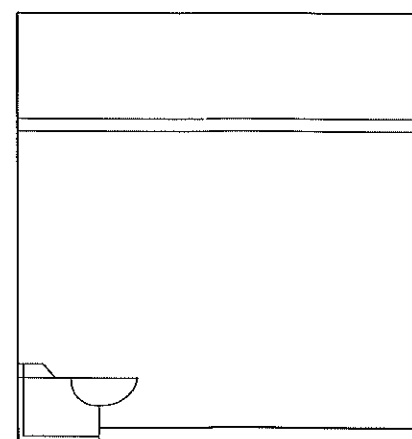

A HC 106 ELEVATION A
Scale: 1/2" = 1'-0"

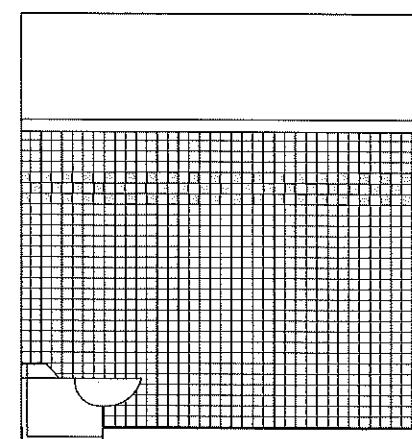

A HC 106 ELEVATION A TILE
Scale: 1/2" = 1'-0"

PROGRESS SET
NOT FOR CONSTRUCTION

NANTUCKET ARCHITECTURE GROUP LTD.
ARCHITECT - DESIGNER - HISTORIC PRESERVATION -
LAND/CAPE
POST OFFICE BOX 1814
NANTUCKET, MA 02554
TELEPHONE: 508.228.5631 FAX: 508.4284

TOWN OF NANTUCKET
NOBADER FARM PLAYING FIELDS CONCESSION STAND
MAP: 69 PARCEL: 1

INTERIOR
ELEVATIONS
SCALE 1/4" = 1'-0"

HDC-03.26.2015, #59588

5/20/15

5/20/15

REVISIONS: 10, JUNE, 2015


REVISIONS:

REVISIONS:


REVISIONS:

D/B: www.copyright.org 2015


130129

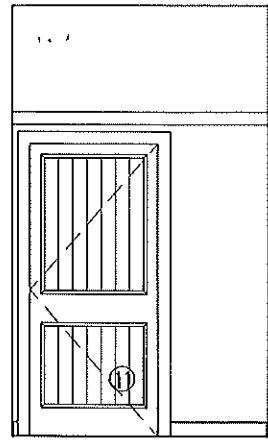


B HC 106 ELEVATION B
Scale: 1/2" = 1'-0"

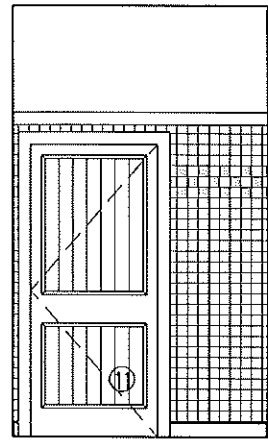


B HC 106 ELEVATION B TILE
Scale: 1/2" = 1'-0"

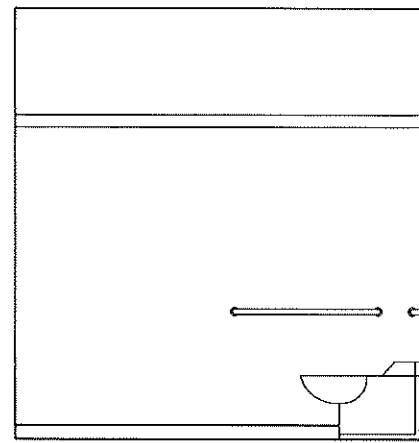


C HC 106 ELEVATION C
Scale: 1/2" = 1'-0"

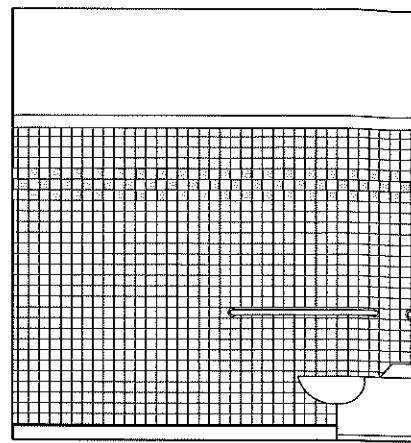


C HC 106 ELEVATION C TILE
Scale: 1/2" = 1'-0"

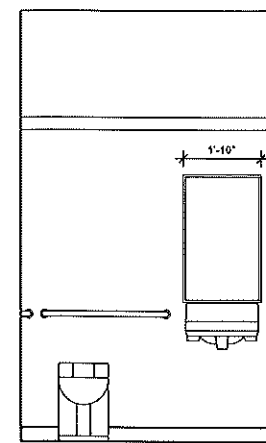


D HC 106 ELEVATION D
Scale: 1/2" = 1'-0"

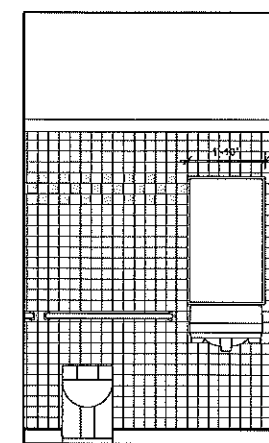


D HC 106 ELEVATION D TILE
Scale: 1/2" = 1'-0"

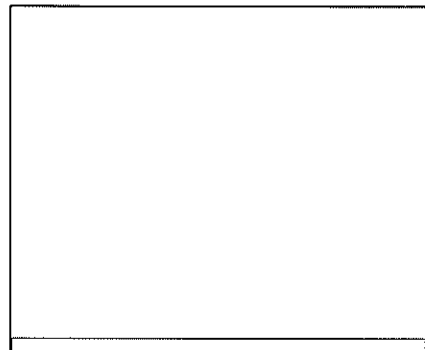


A OFFICIALS ROOM 004 ELEVATION A
Scale: 1/2" = 1'-0"

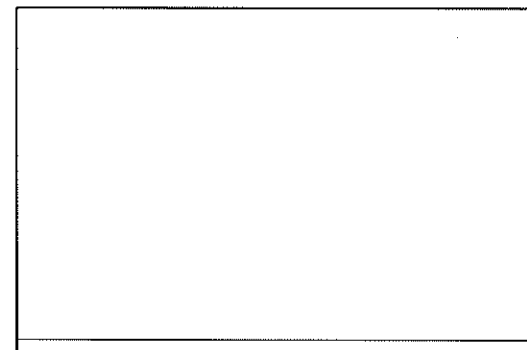


B OFFICIALS ROOM 004 ELEVATION B
Scale: 1/2" = 1'-0"

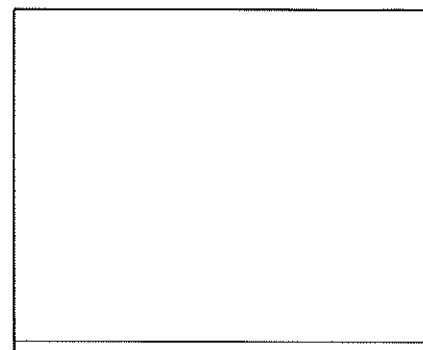


C OFFICIALS ROOM 004 ELEVATION C
Scale: 1/2" = 1'-0"

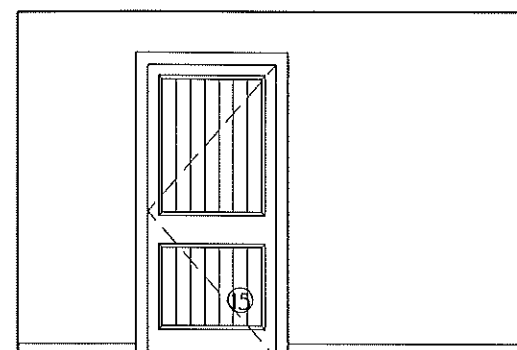


D OFFICIALS ROOM 004 ELEVATION D
Scale: 1/2" = 1'-0"

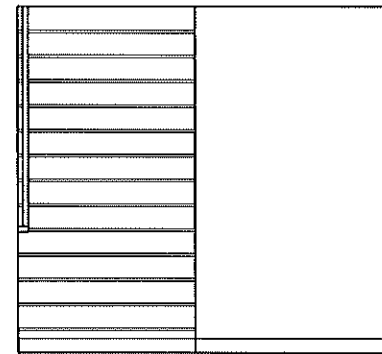


A EXIT HALL 003 ELEVATION A
Scale: 1/2" = 1'-0"

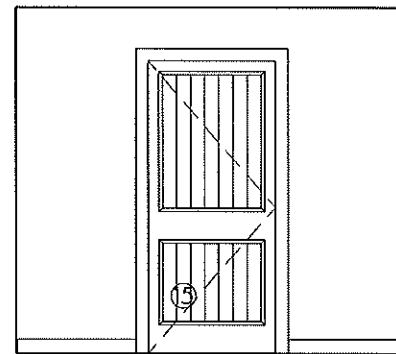


B EXIT HALL 003 ELEVATION B
Scale: 1/2" = 1'-0"

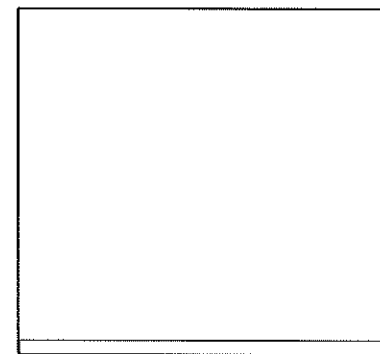


C EXIT HALL 003 ELEVATION C
Scale: 1/2" = 1'-0"

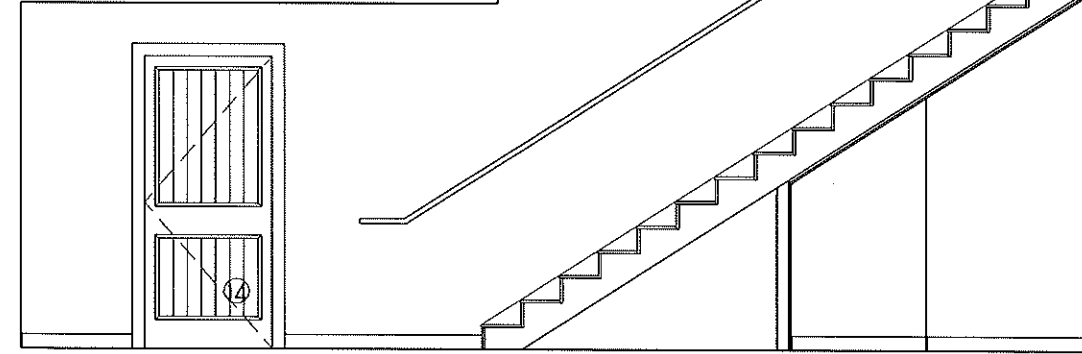


D EXIT HALL 003 ELEVATION D
Scale: 1/2" = 1'-0"

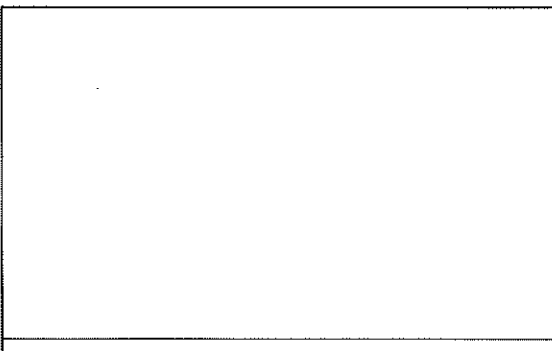

A UTILITY ROOM 005 ELEVATION A
Scale: 1/2" = 1'-0"

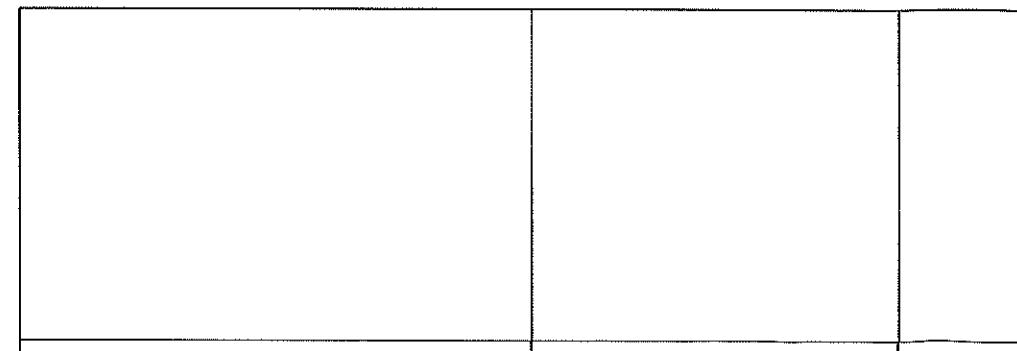

B UTILITY ROOM 005 ELEVATION B
Scale: 1/2" = 1'-0"

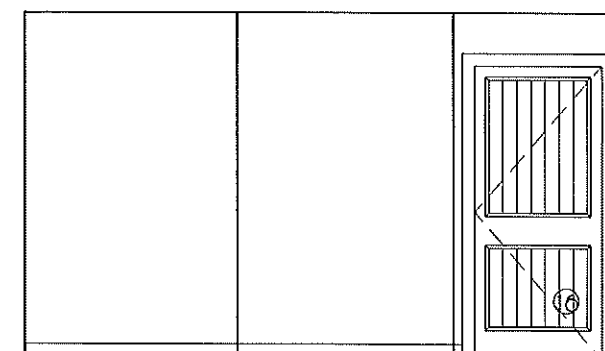

C UTILITY ROOM 005 ELEVATION C
Scale: 1/2" = 1'-0"

PROGRESS SET
NOT FOR CONSTRUCTION

NANTUCKET ARCHITECTURE GROUP LTD.
ARCHITECTS - DESIGNERS - HISTORIC PRESERVATION -
LAND/CAPE
P.O. BOX 1814
NANTUCKET, MA 01904
TELEPHONE: 508.228.5651 FAX: 508.4284


TOWN OF NANTUCKET
NOBADER FARM PLAYING FIELD/ CONCESSION STAND
MAP: 69 PARCEL: 1

INTERIOR
ELEVATION/
SCALE: 1/4" = 1'-0"


HDC: 05.26.2015, #59388
DRAWING
PLDG DEPT.
REVISIONS: 10, JUNE, 2015
REVISIONS:
REVISIONS:
REVISIONS:
D/B, Wm copyright 2015

1301.29


A10

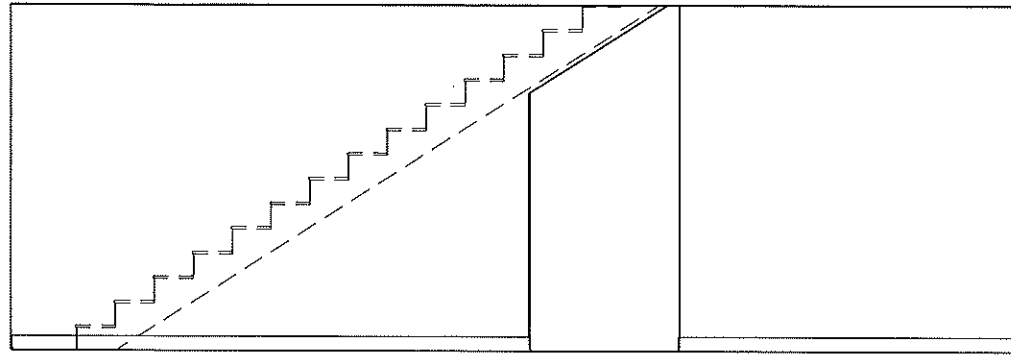


D UTILITY ROOM 005 ELEVATION D
Scale: 1/2" = 1'-0"

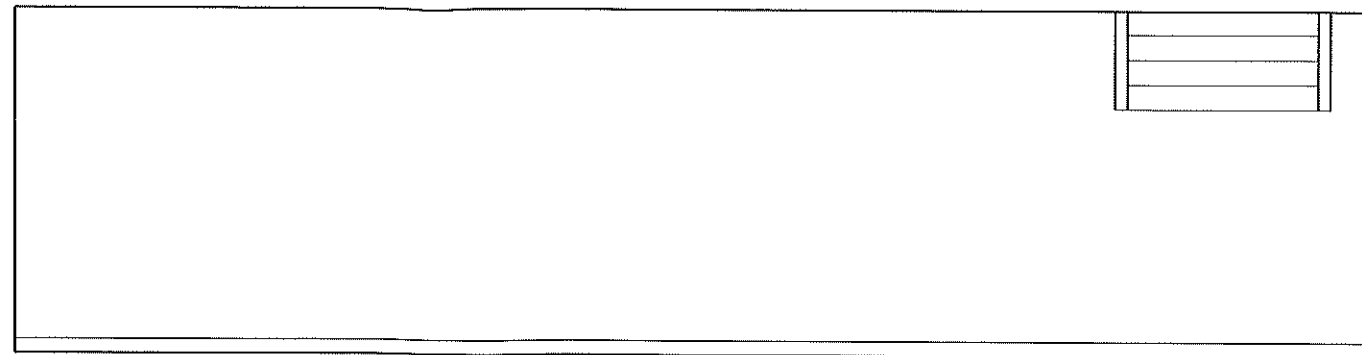


A STORAGE 001 ELEVATION A
Scale: 1/2" = 1'-0"

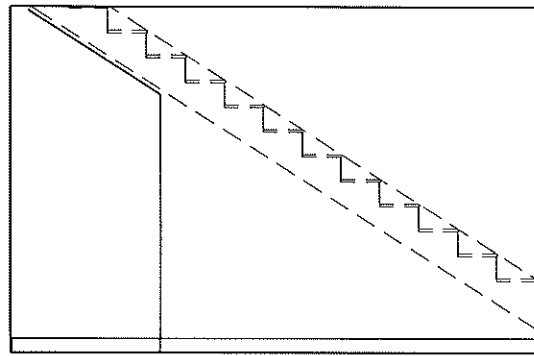


B STORAGE 001 ELEVATION B
Scale: 1/2" = 1'-0"

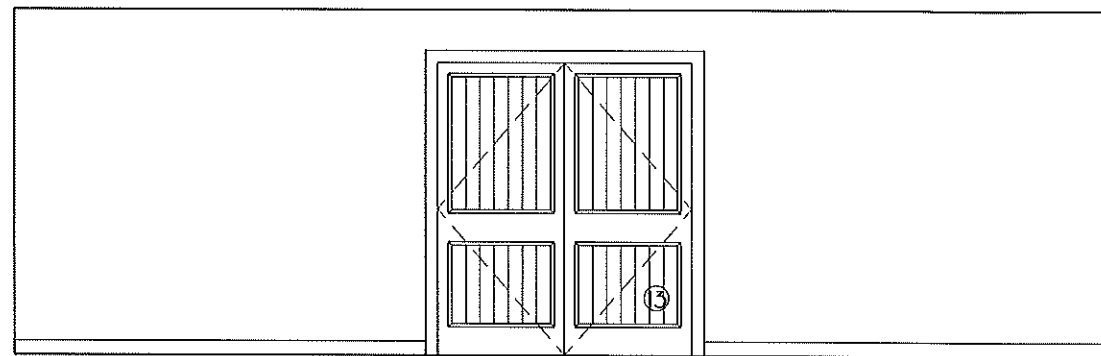


C STORAGE 001 ELEVATION C
Scale: 1/2" = 1'-0"

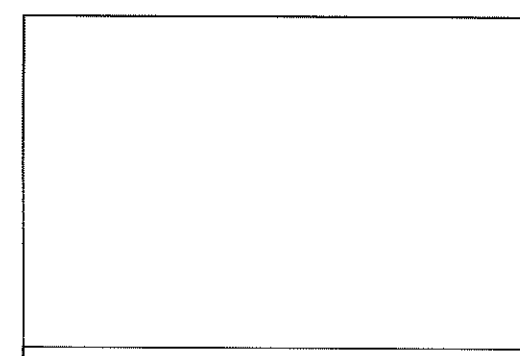


D STORAGE 001 ELEVATION D
Scale: 1/2" = 1'-0"

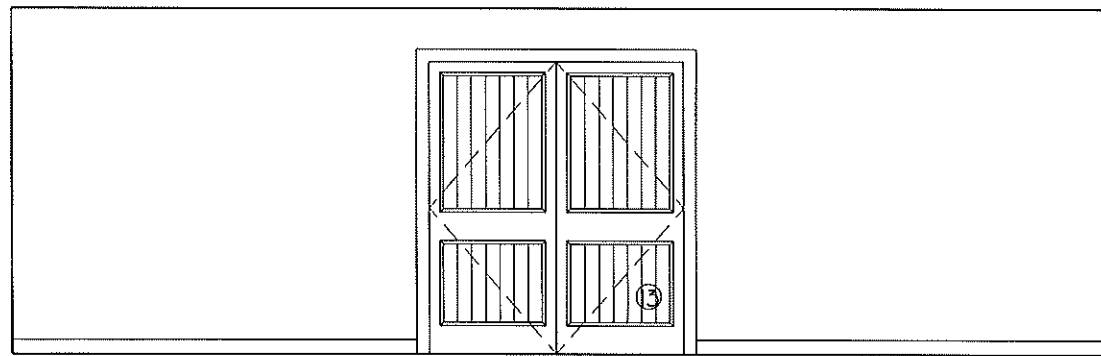


A CONFERENCE 002 ELEVATION A
Scale: 1/2" = 1'-0"

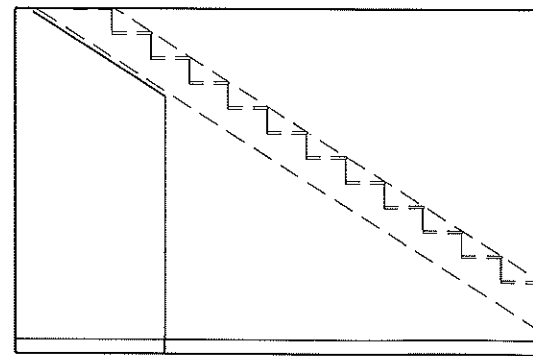

B STORAGE 001 ELEVATION B
Scale: 1/2" = 1'-0"

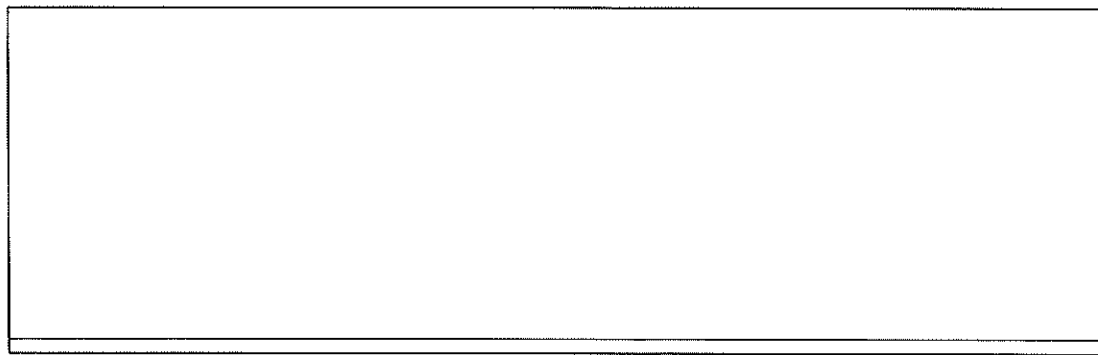

C CONFERENCE 002 ELEVATION C
Scale: 1/2" = 1'-0"

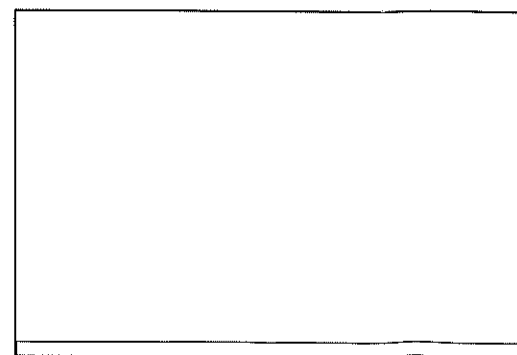

D CONFERENCE 002 ELEVATION D
Scale: 1/2" = 1'-0"

PROGRESS SET
NOT FOR CONSTRUCTION

NANTUCKET ARCHITECTURE GROUP LTD.
ARCHITECT - DESIGNER - HISTORIC PRESERVATION -
LANDSCAPE
POST OFFICE BOX 1814
NANTUCKET, MASSACHUSETTS 02554
TELEPHONE: 508.228.5631 FAX: 508.4284


TOWN OF NANTUCKET
MOBADER FARM PLAYING FIELDS CONCESSION STAND
MAP: 69 PARCEL: 1

INTERIOR
ELEVATIONS
SCALE 1/4" = 1'-0"
NDC-05.26.2013, #59588
BDDNG
BLDG DEPT
REVISED: 10, JUNE, 2013
REVISED:
REVISED:
REVISED:
D/B, vrm copyright 2013
130129

A11



BLW Engineers, Inc.
 311 Great Road, Post Office Box 1551
 Littleton, Massachusetts 01450
 t: 978.486.4301 e: 978.428.0967
 www.blwengineers.com
 HVAC • Electrical • Plumbing • Fire Protection

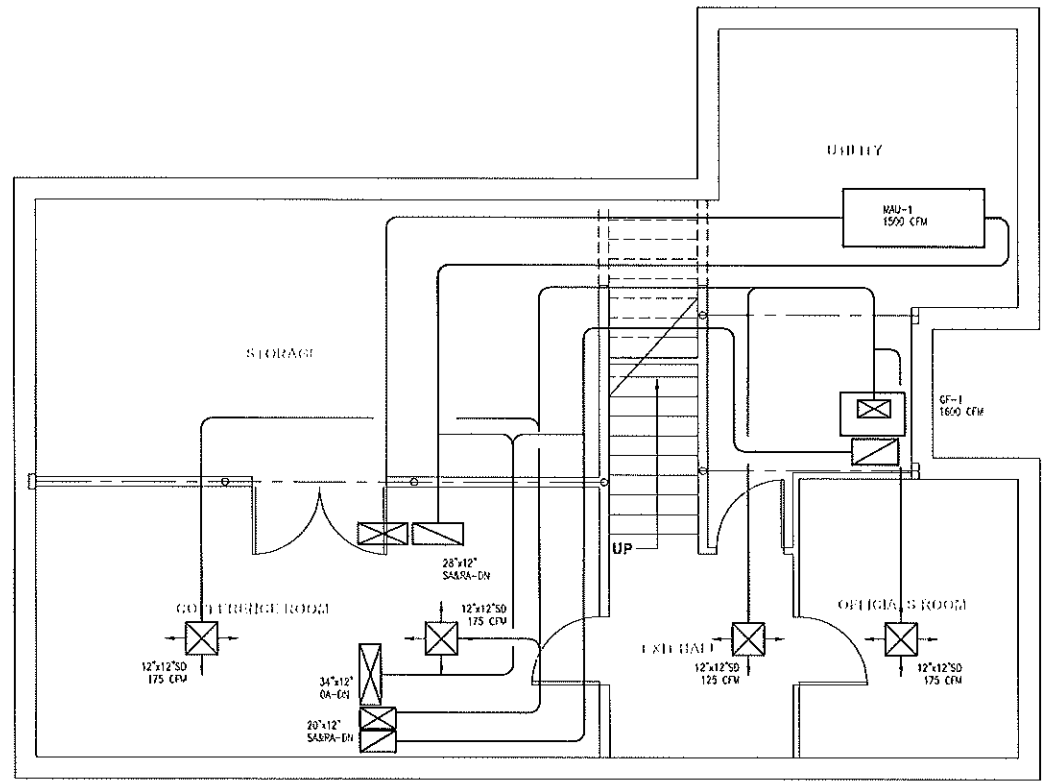

① HVAC - Basement Plan
 SCALE: 1/4" = 1'-0"

NANTUCKET ARCHITECTURE GROUP LTD.
 ARCHITECTS - DESIGNERS - HISTORIC PRESERVATION - LANDSCAPE
 POST OFFICE BOX 1814
 NANTUCKET, MASSACHUSETTS 02554
 TELEPHONE: 508.228.5631 FAX: 325.4284

TOWN OF NANTUCKET
 NOBADEER FARM PLAYING FIELDS CONCESSION
 STAND
 MAP: 69 PARCEL: 1

HVAC
 BASEMENT
 FLOOR PLAN


DRG:
DESIGN:
ARCH. DEPT:
REVISIONS:
REVISIONS:
REVISIONS:
REVISIONS:
REVISIONS:

©/P. wmm copyright nag 2011

H1.1



BLW Engineers, Inc.
 311 Great Road, Post Office Box 1551
 Littleton, Massachusetts 01469
 t: 978.486.4301 f: 978.428.0967
 www.blwengineers.com
 HVAC • Electrical • Plumbing • Fire Protection

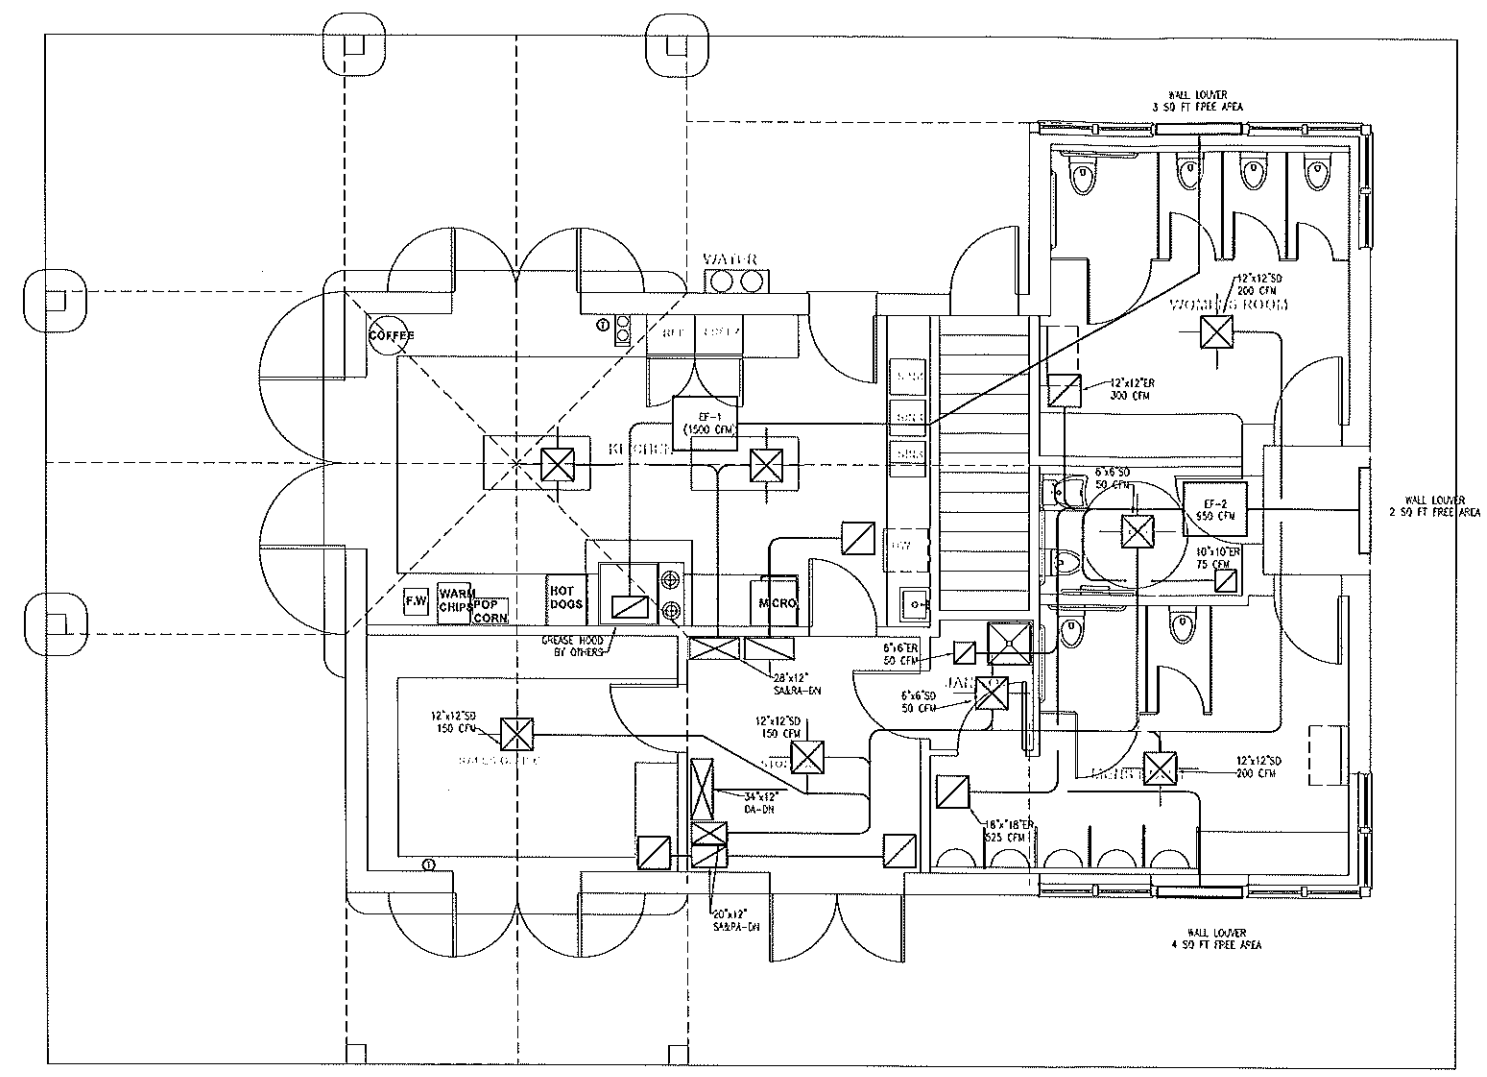

1 HVAC - Floor Plan
 SCALE: 1/4" = 1'-0"

NANTUCKET ARCHITECTURE GROUP LTD.
 ARCHITECTS - DESIGNERS - HISTORIC PRESERVATION - LANDSCAPE
 POST OFFICE BOX 1814
 NANTUCKET, MASSACHUSETTS 02554
 TELEPHONE: 508.228.5631 FAX: 508.4284

TOWN OF NANTUCKET
 NOBADER FARM PLAYING FIELDS CONCESSION
 STAND
 MAP: 69 PARCEL: 1

HVAC FLOOR PLAN

NO.
REVISIONS:
DATE:
BY:
REVISIONS:
DATE:
BY:
REVISIONS:
DATE:
BY:

H1.2